
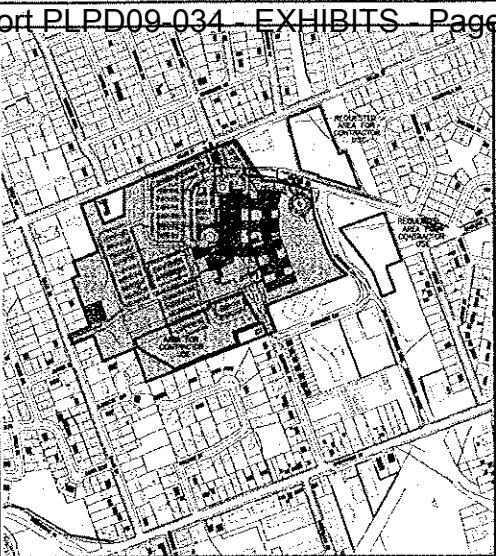


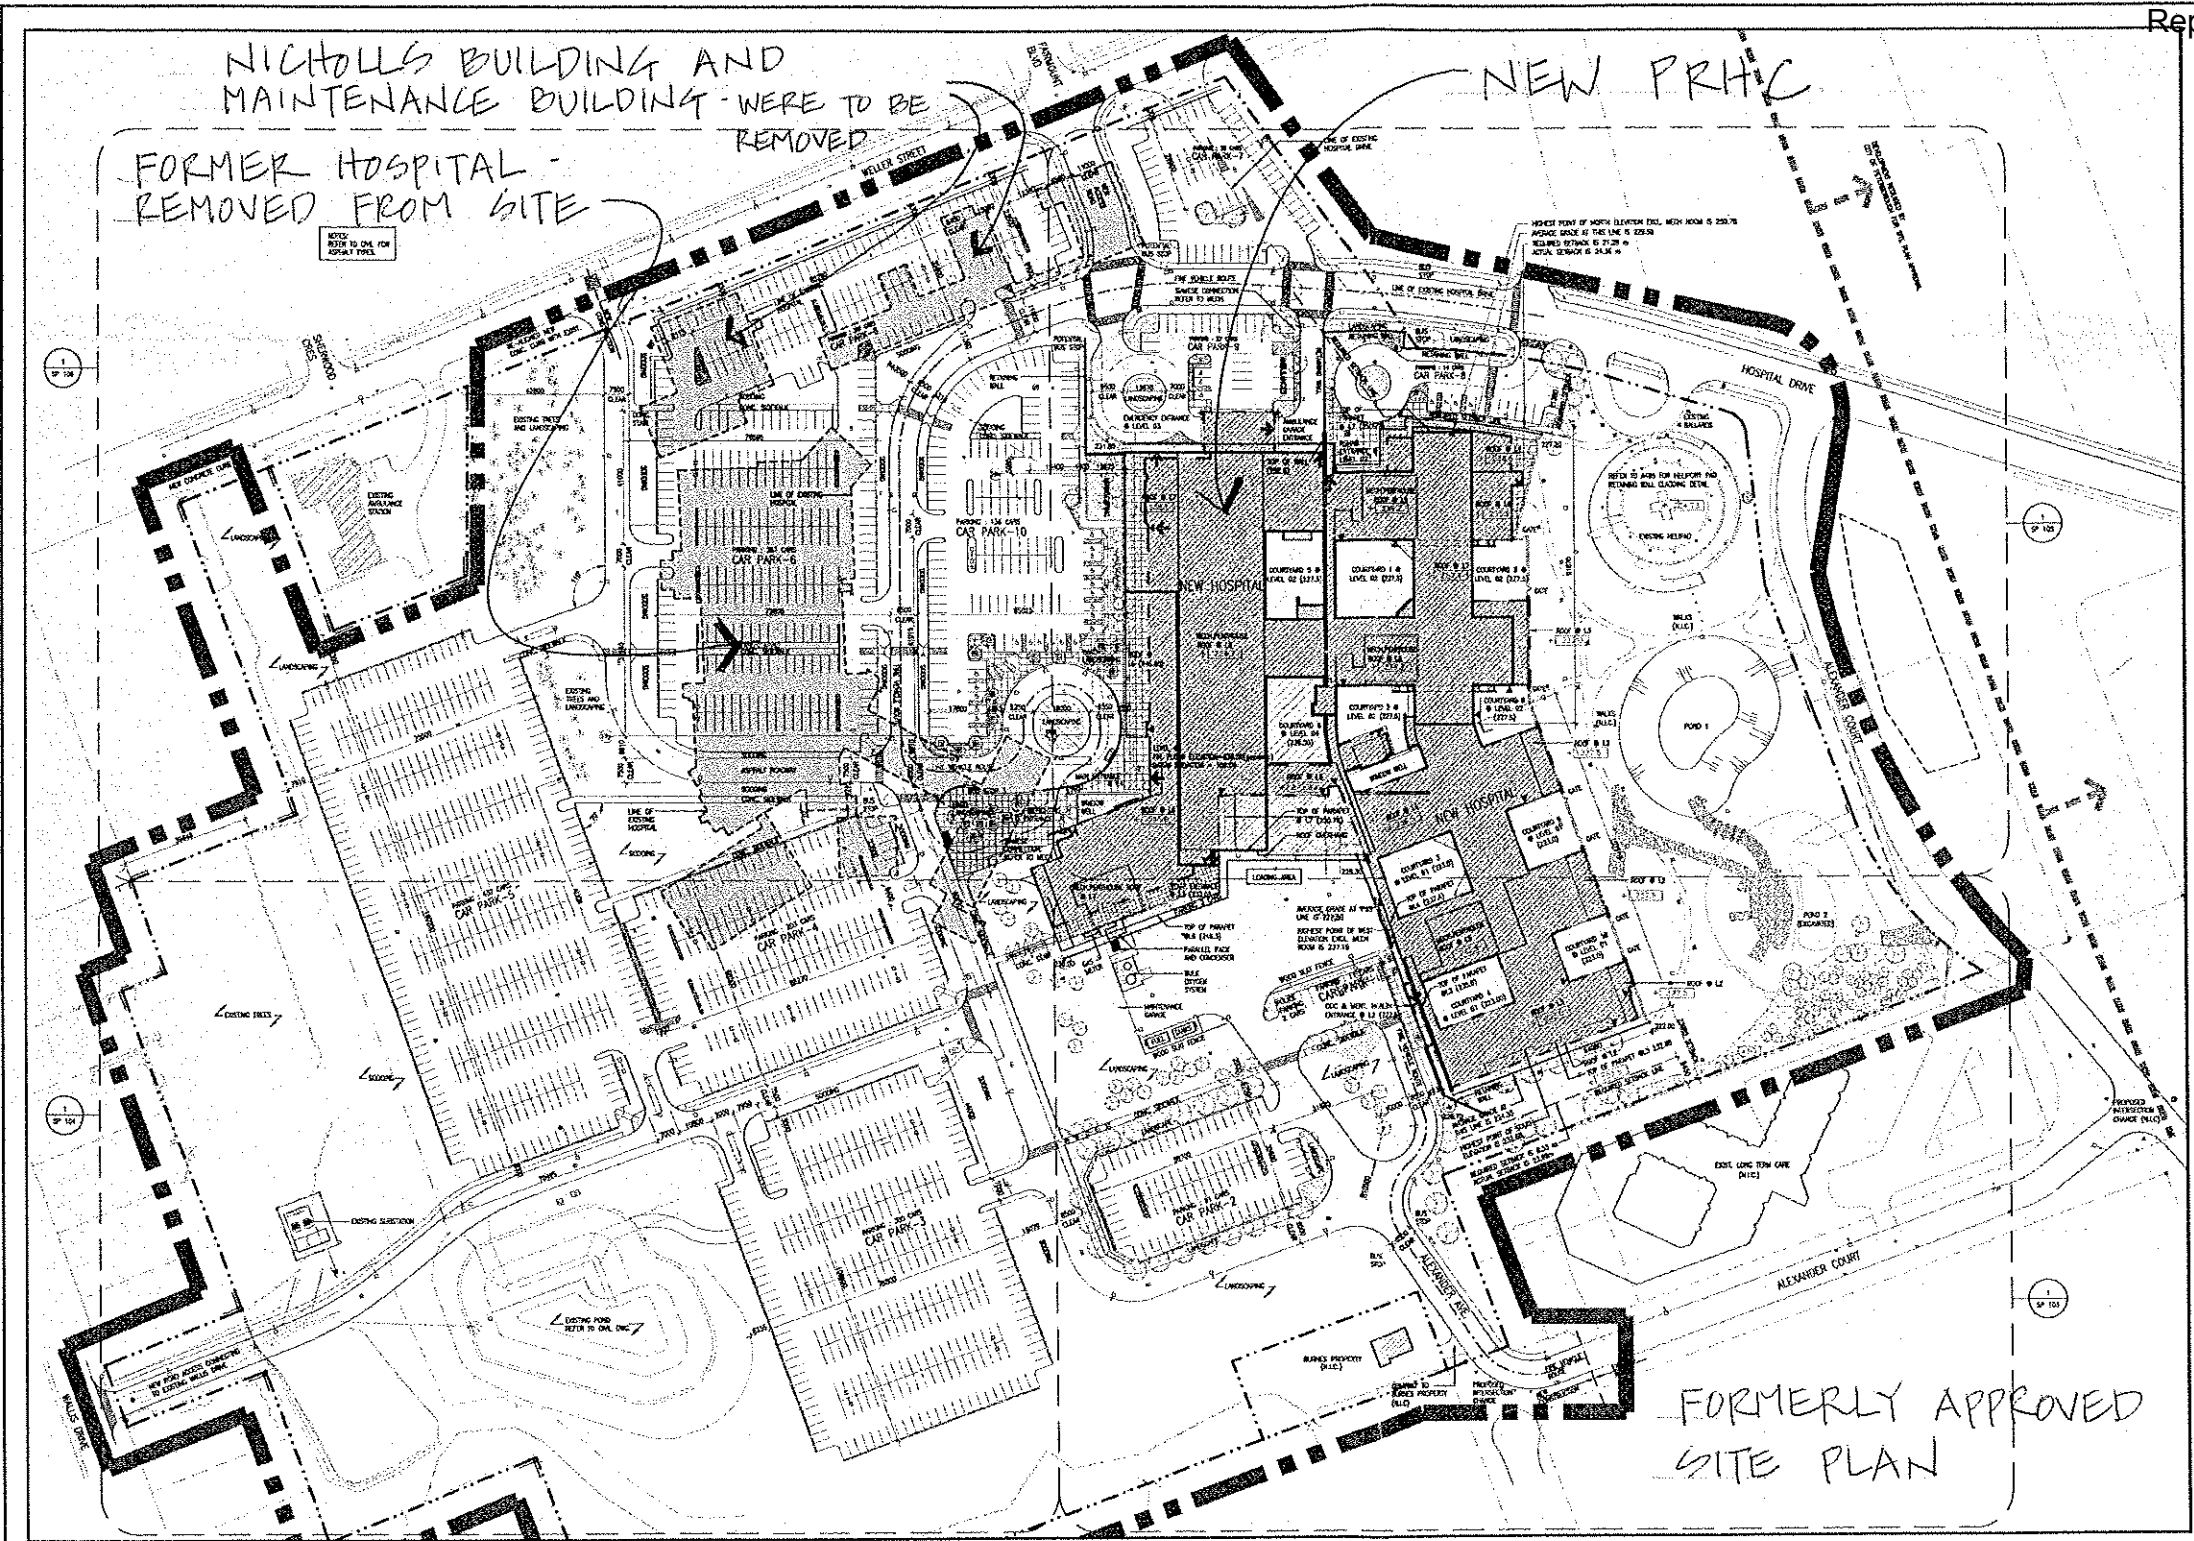

2 CONTEXT PLAN
SCALE: 1=5000

LEGEND

- PUBLIC/STAFF ENTRANCES
- EMERGENCY EXITS
- PEDESTRIAN CROSSWALK
- NO PARKING AREAS
- EXTENT OF WORK IN THIS CONTEXT
- LINE OF EXISTING PUBLIC BALDING FOOTPRINT

THIS DRAWING ISSUED FOR:


1	20.01.01	ISSUED FOR APPROVAL NO. 1
COMPLETE DRAWING SET ISSUED		
12	11.04.01	FOR SITE PLAN APPROVAL
13	12.01.01	FOR ROAD & PAVEMENT
14	12.01.01	FOR ROAD & PAVEMENT
15	12.01.01	FOR ROAD & PAVEMENT
100	12.01.01	FOR ROAD & PAVEMENT

SITE PLAN				BUILDING CODE CLASSIFICATION PART-3 FOR THE PROPOSED HOSPITAL			FIRE ALARM SYSTEM				
SCALE: 1:750							REQUIRED				
SITE STATISTICS							PROVIDED				
	SO.FT.	M ²	COVERAGE	PARKING	REQUIRED	PROVIDED					
SITE AREA	1,847,607	171,648	100%	STANDARD	1573	1618	YES				
EXISTING BUILDING FOOTPRINT	0.00	0.00	0%	HANDICAPPED	27	32	YES				
NEW BUILDING FOOTPRINT	259,699	24,126	14.06%	TOTAL	1600	1650	YES				
TOTAL BUILDING FOOTPRINT	259,699	24,126	14.06%				YES				
MAXIMUM BUILDING COVERING ALLOWED			40%				YES				
TOTAL PAVED PARKING AREA	534,853	49,692	28.95%				YES				
LANDSCAPE OPEN AREA	840,695	78,100	45.50%				YES				
VEHICLE CIRCULATION	212,360	19,730	11.49%				YES				

BUILDING AREA	750,882 SO.FT.(69,757 SO.M.)
BUILDING USE AND CLASSIFICATION	GROUP-B DIVISION-2.3.2.2.38
NO.OF STOREYS	6
SPRINKLER SYSTEM REQUIRED PROVIDED	YES YES
CONSTRUCTION ASSEMBLY REQUIRED PROVIDED	NON COMBUSTIBLE NON COMBUSTIBLE
REQUIRED FIRE RATING FLOORS MEZZANINES ROOFS SUPPORT STRUCTURE	2 HOUR. 1 HOUR. RATING WAIVED BY SPRINKLER SYSTEM SAME AS SUPPORTED ASSEMBLY

FIRE ALARM SYSTEM REQUIRED PROVIDED	YES YES
STANDPIPE SYSTEM REQUIRED PROVIDED	YES YES
HIGH BUILDING CLASSIFICATION	YES
SPATIAL SEPARATION ELEVATION	NORTH 100% SOUTH 100% EAST 100% WEST 100%
AREA OF UNPROTECTED OPENINGS PERMITTED FIRE RATING	0 0 0 0

Exhibit A
Page 1 of 2

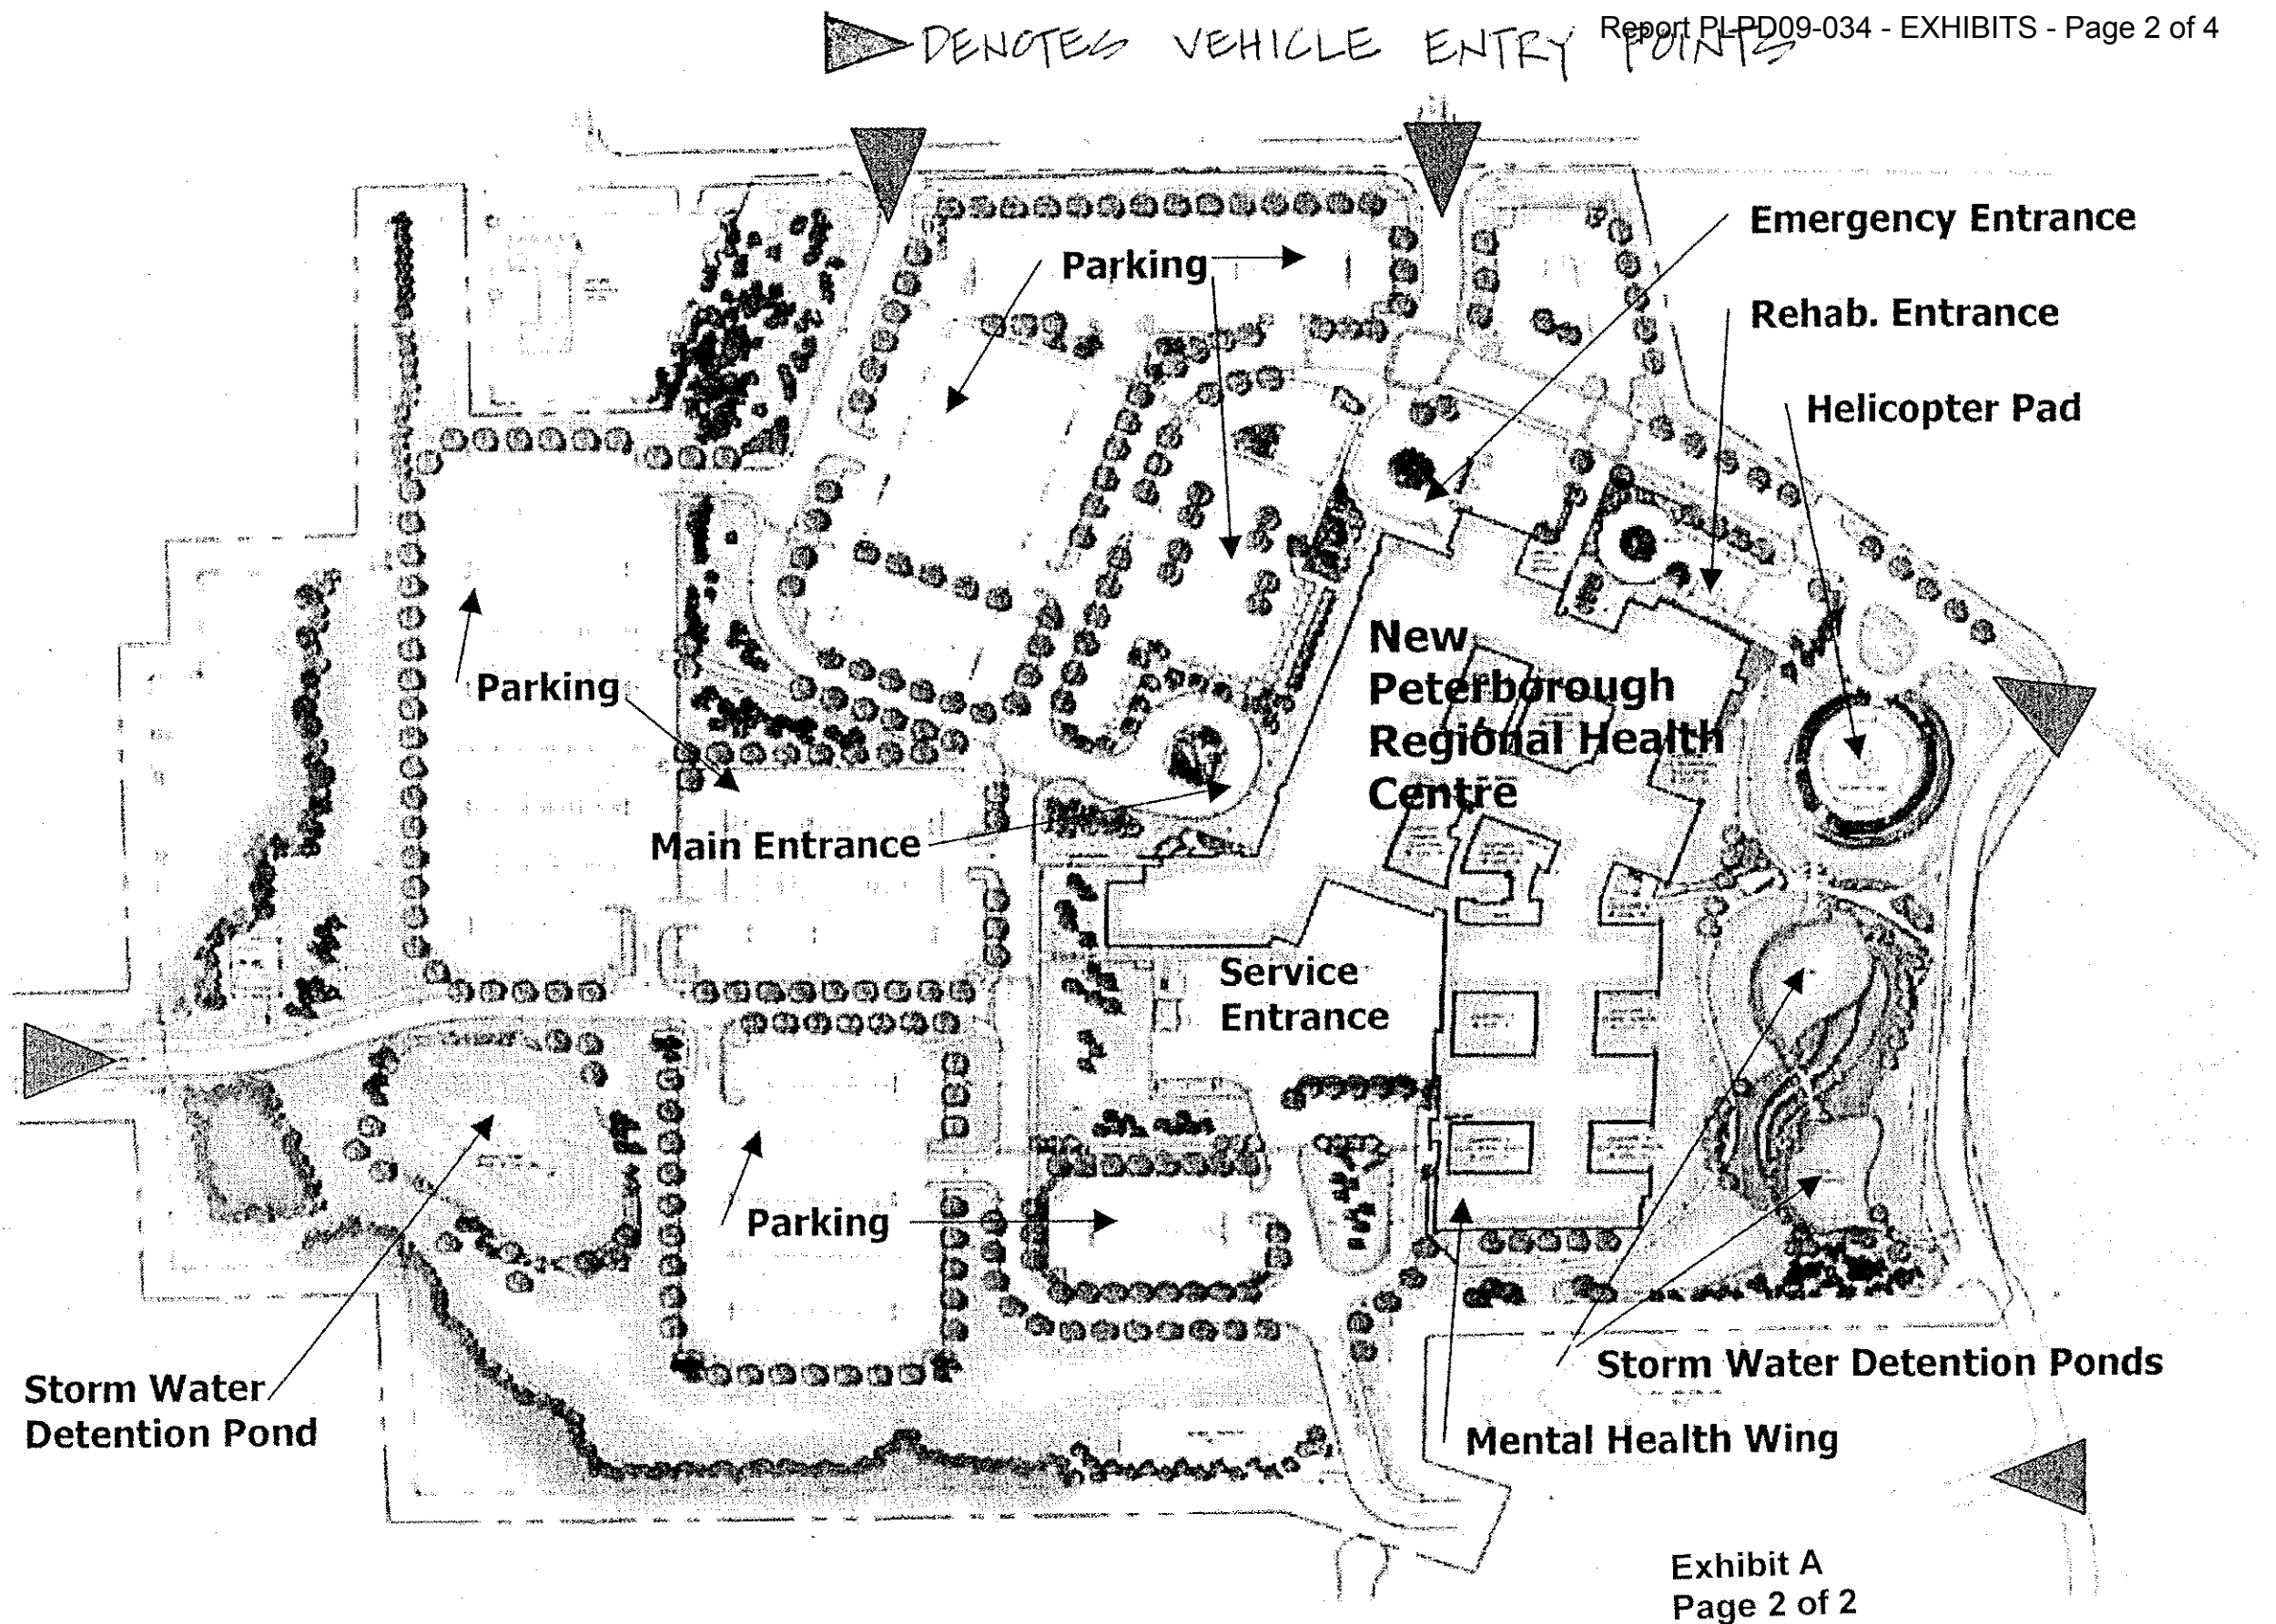

PETERBOROUGH REGIONAL HEALTH CENTRE
 LANDSCAPE DEVELOPMENT MASTERPLAN
ARCHITECTURE & PLANNING • LANDSCAPE ARCHITECTURE

Exhibit A
 Page 2 of 2

LANDSCAPE PLAN AND SITE FEATURES.

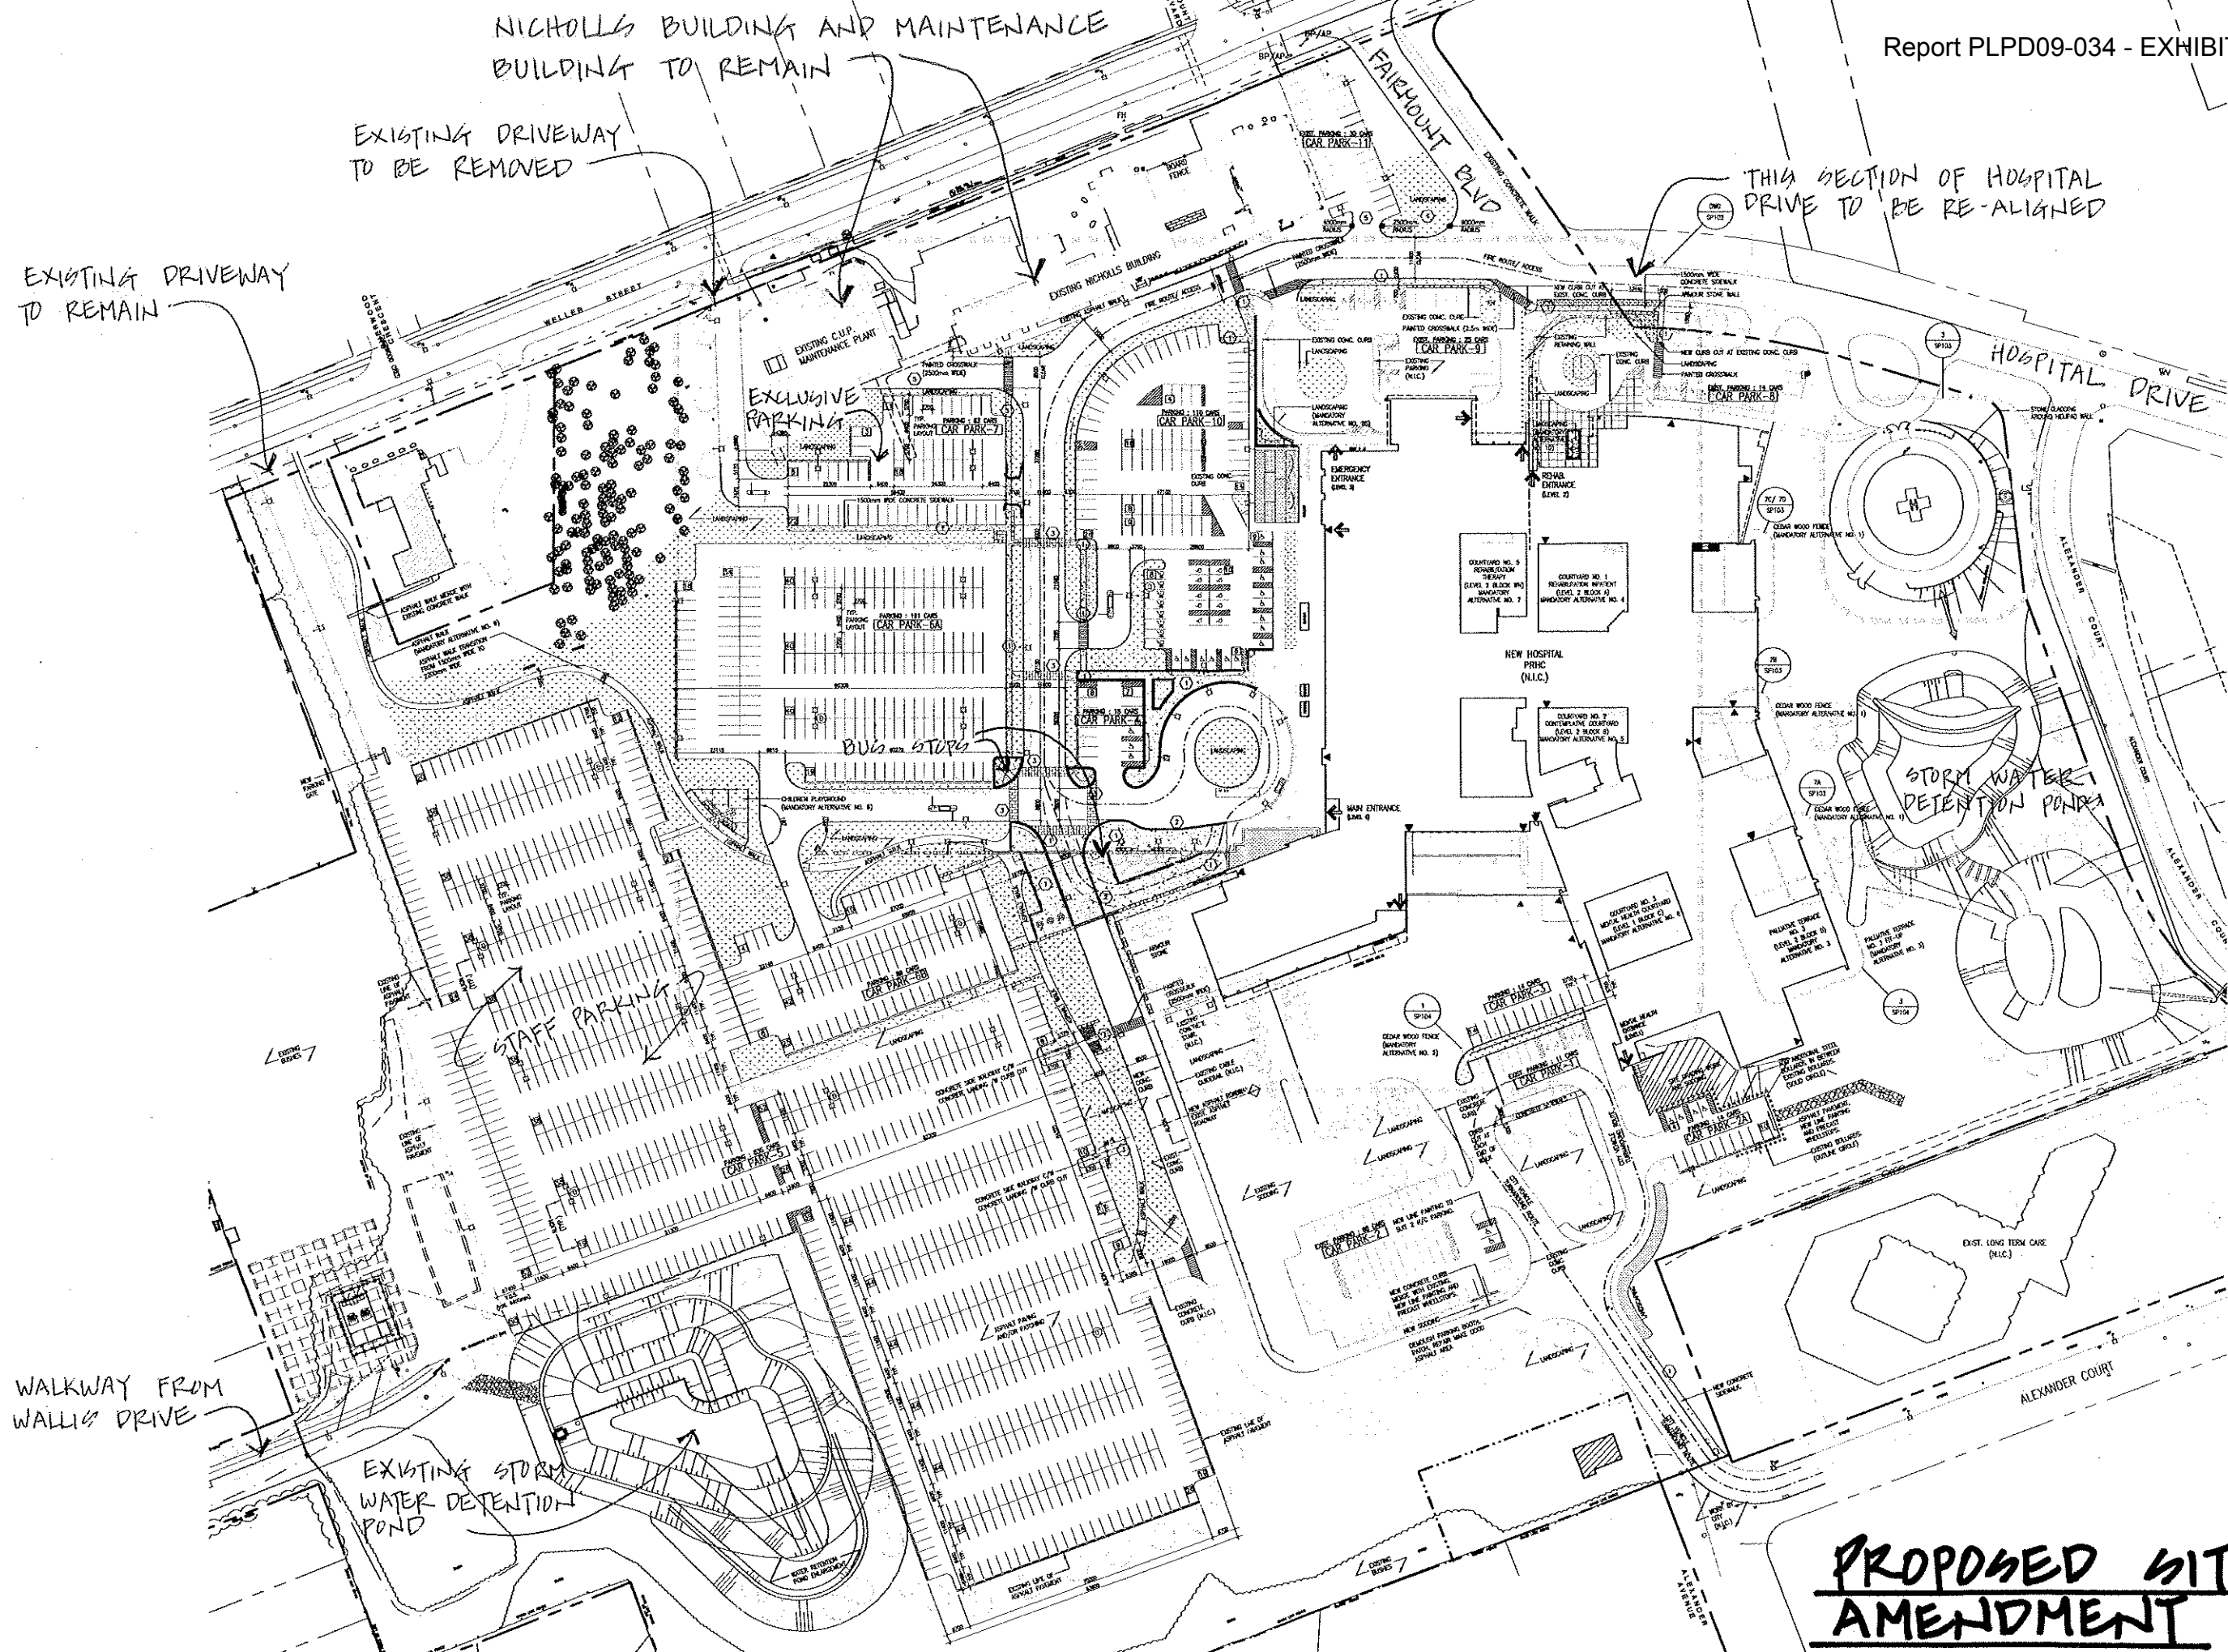


Exhibit B
Page 1 of 1

**PROPOSED SITE PLAN
AMENDMENT**

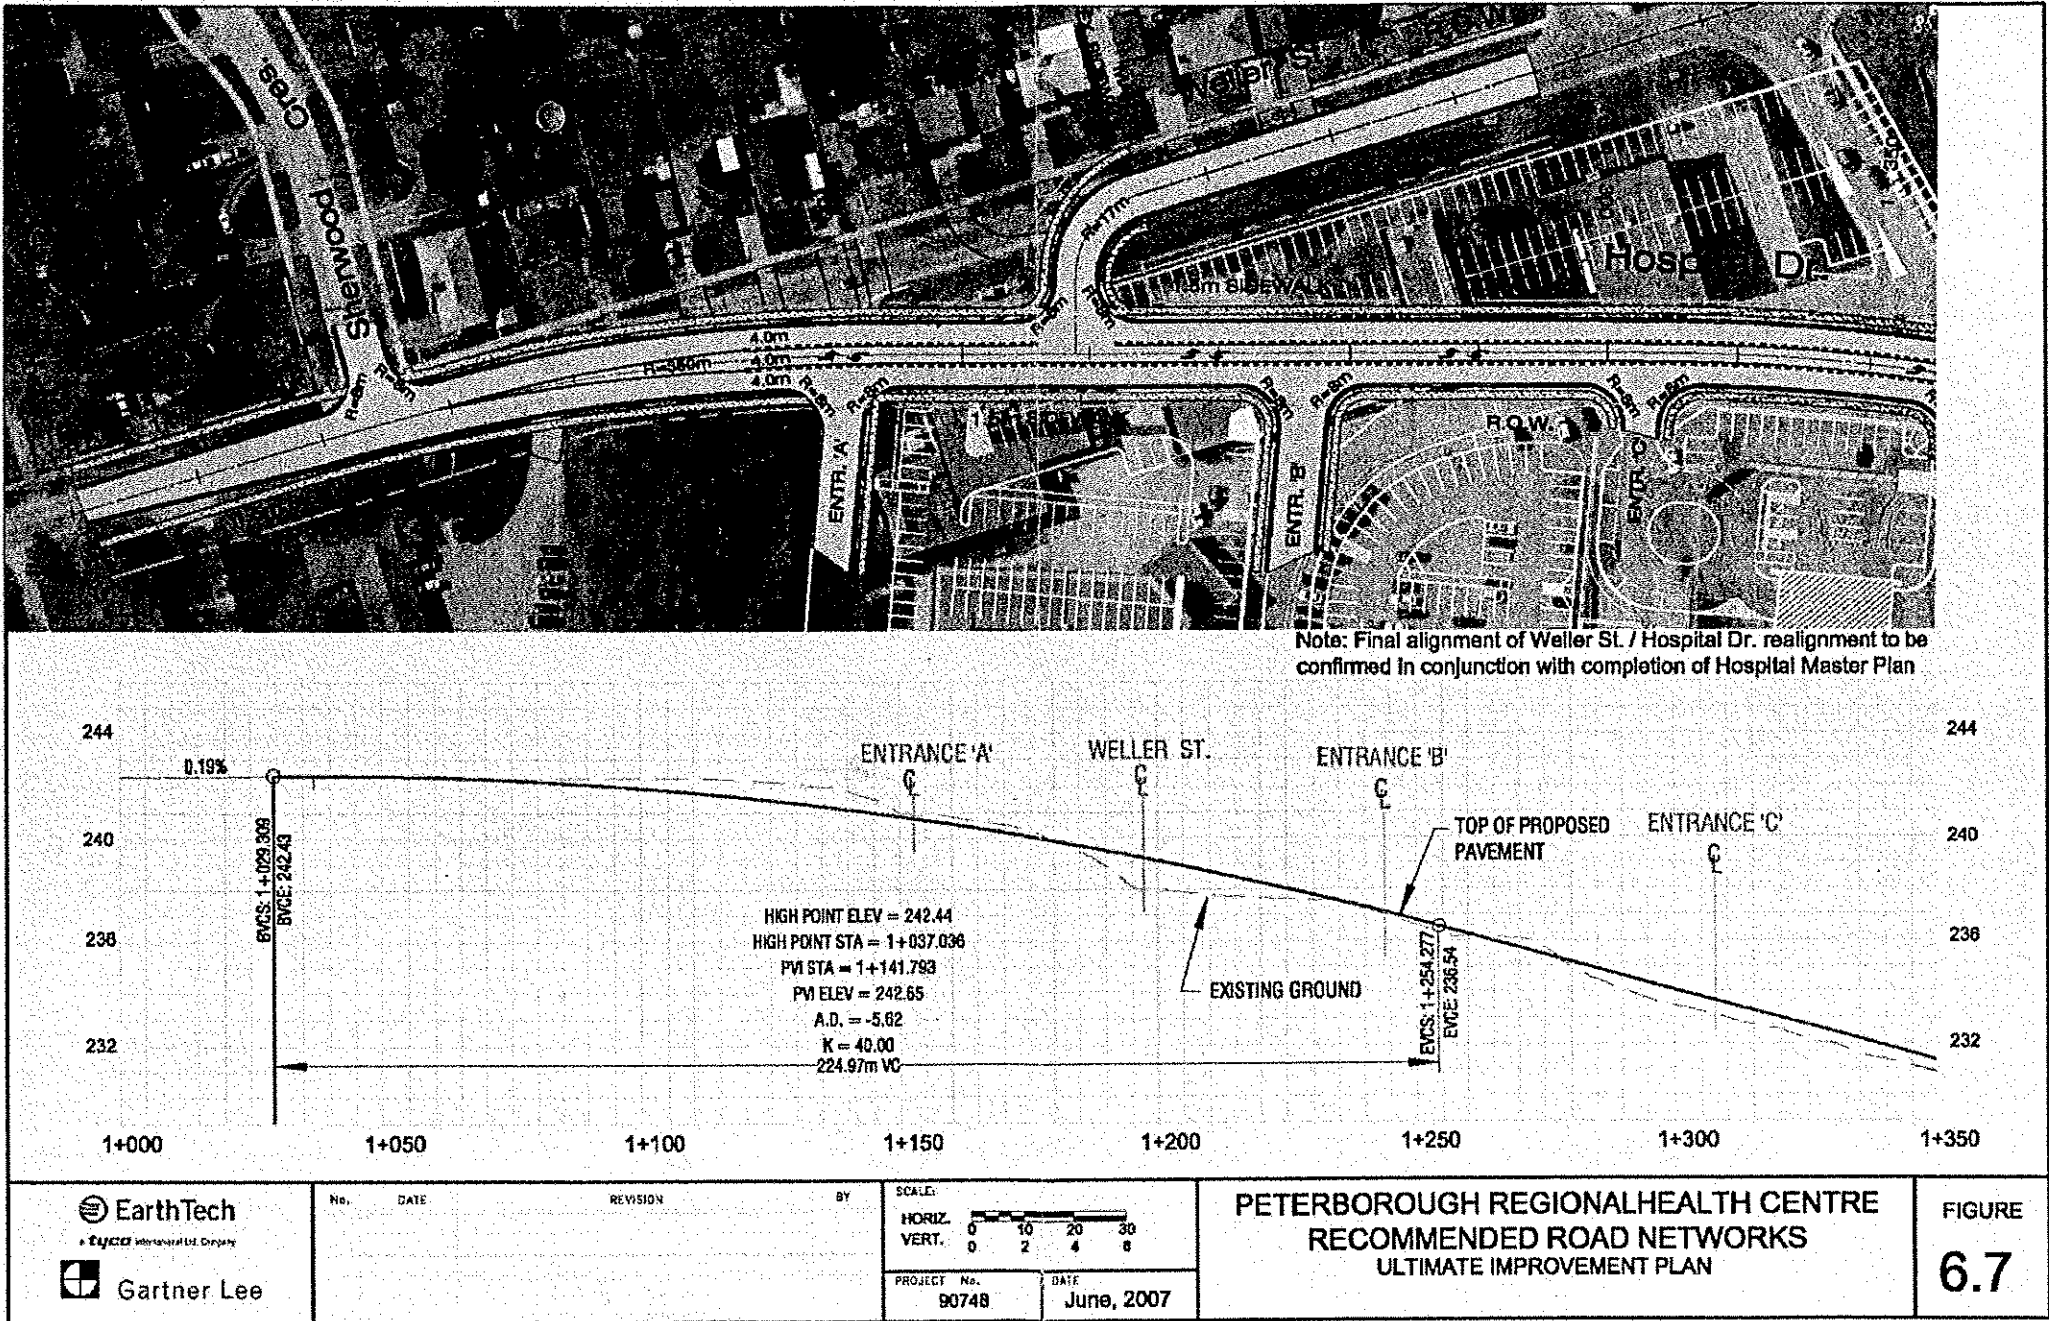


Exhibit C
Page 1 of 1

HOSPITAL DRIVE EXTENSION (PHASE 2 -
PRHC ROAD NETWORK IMPROVEMENT PLAN)